
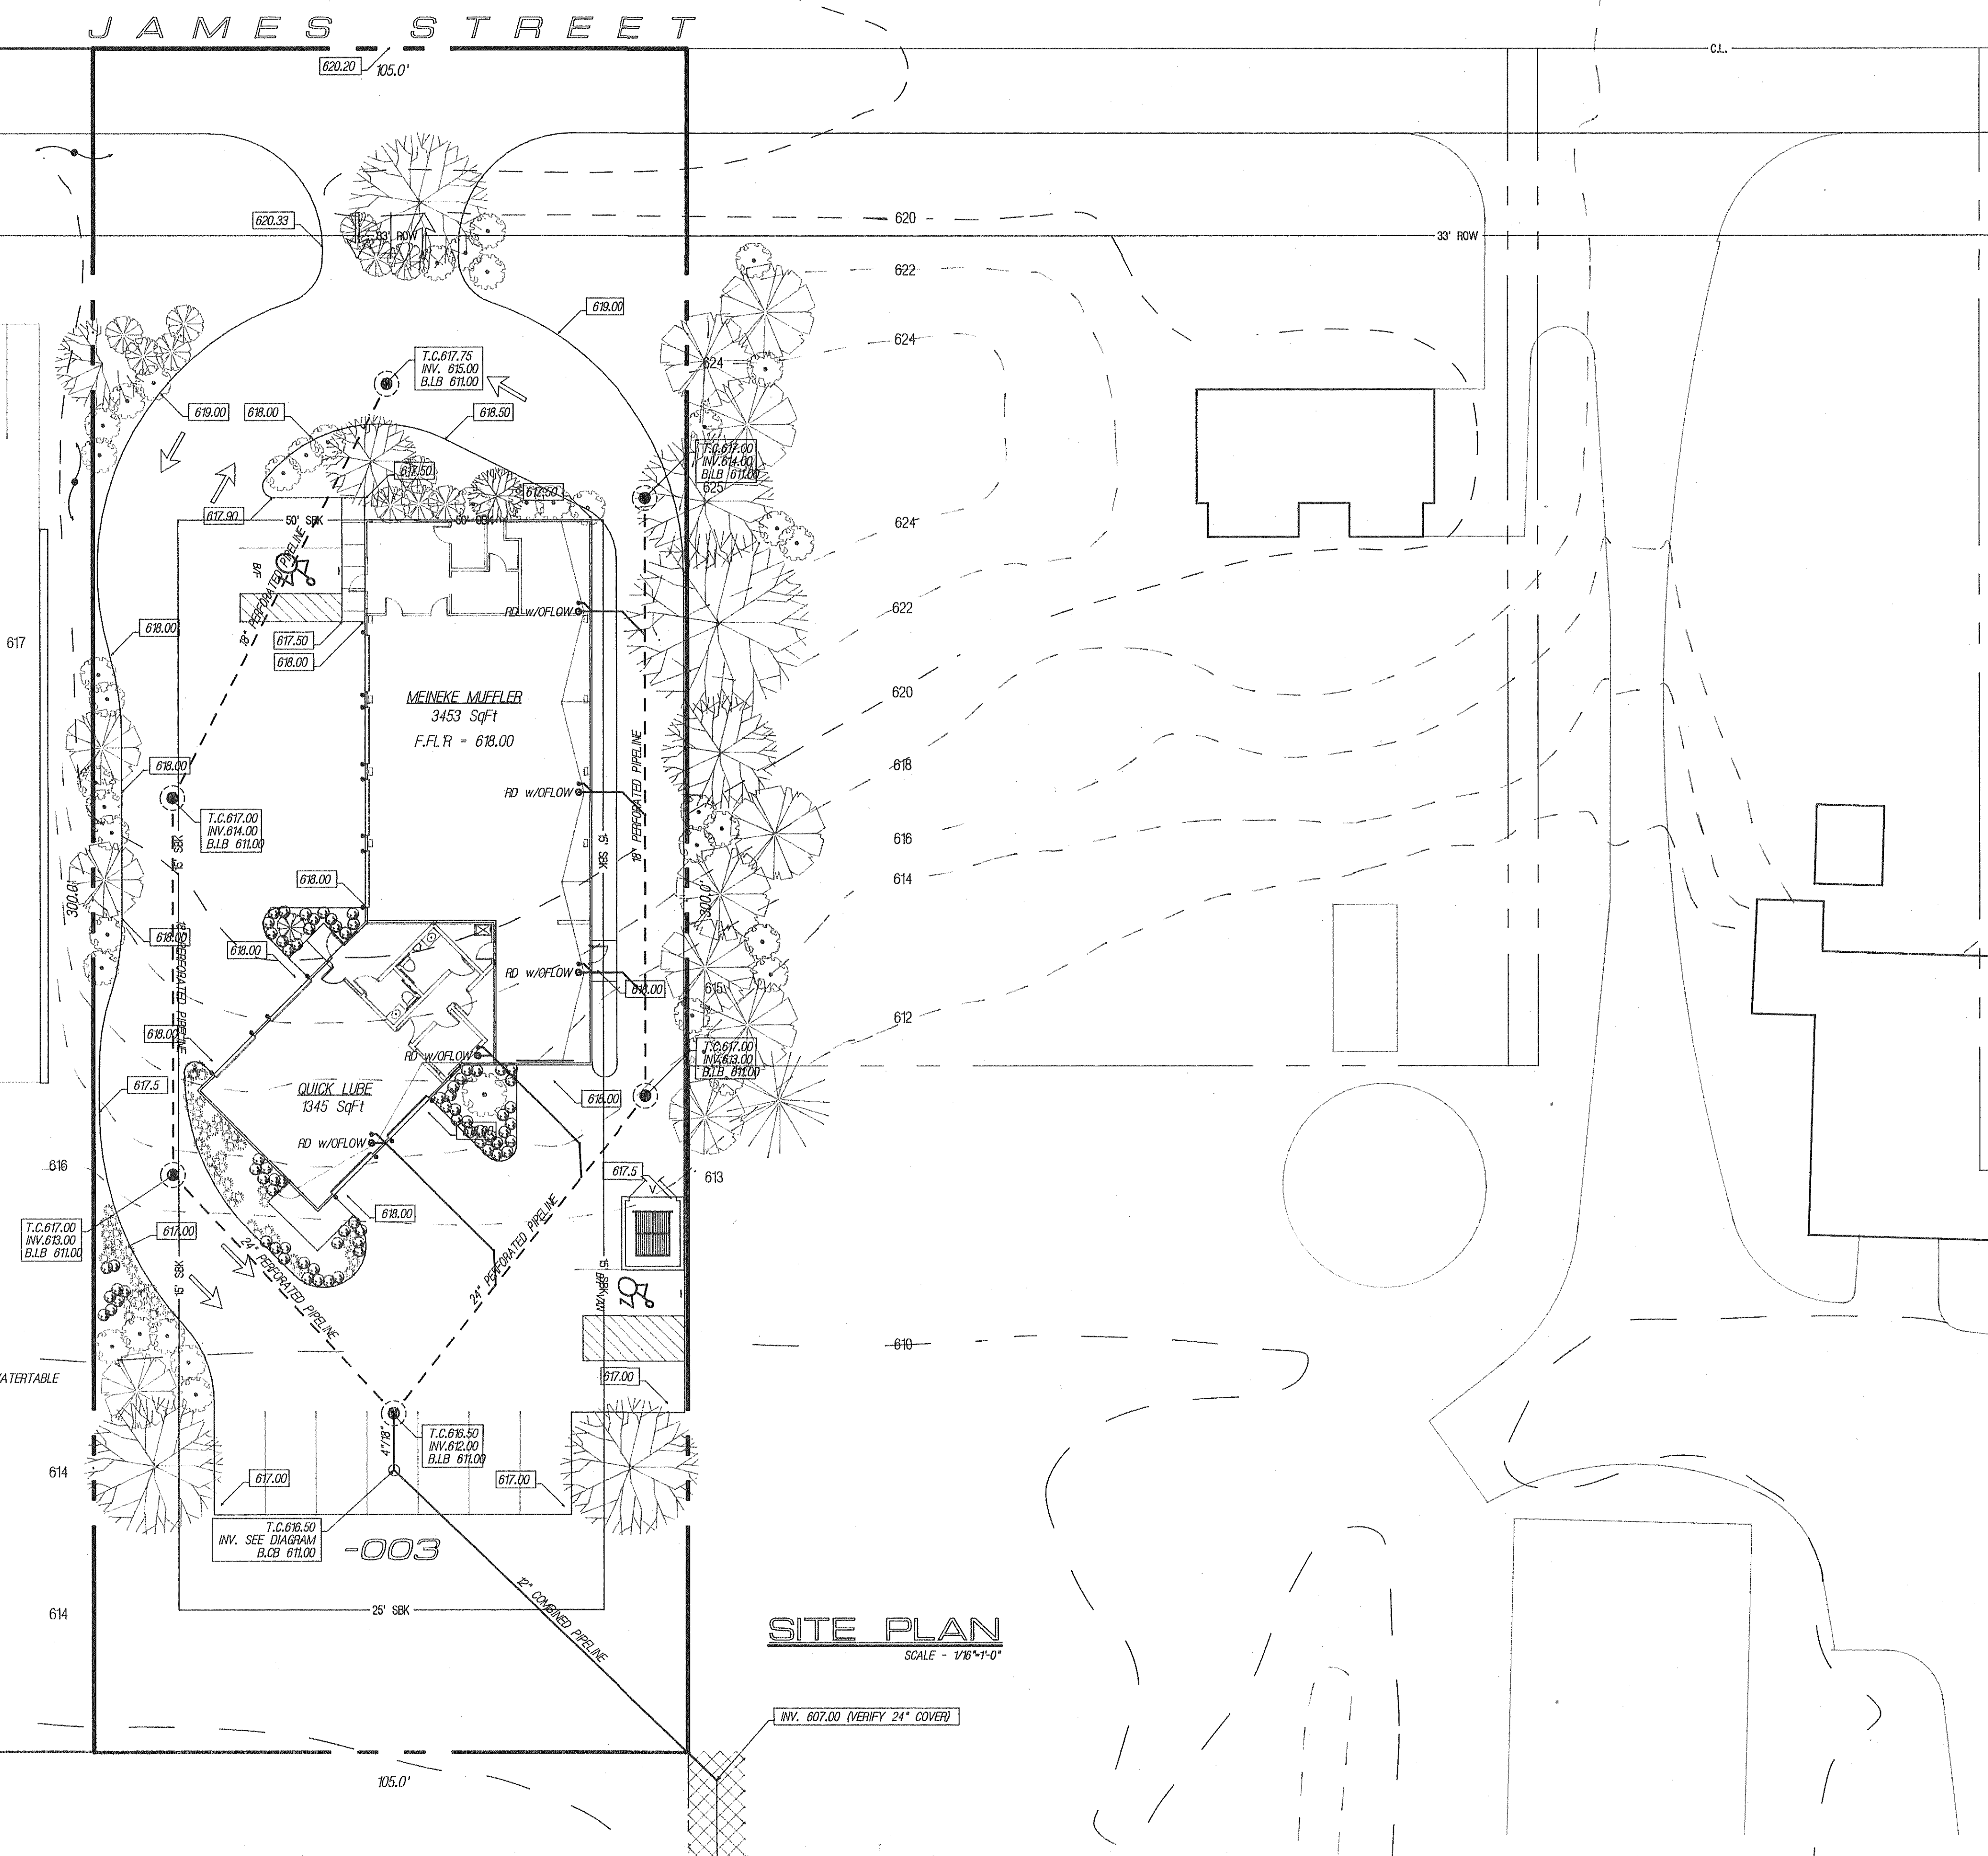


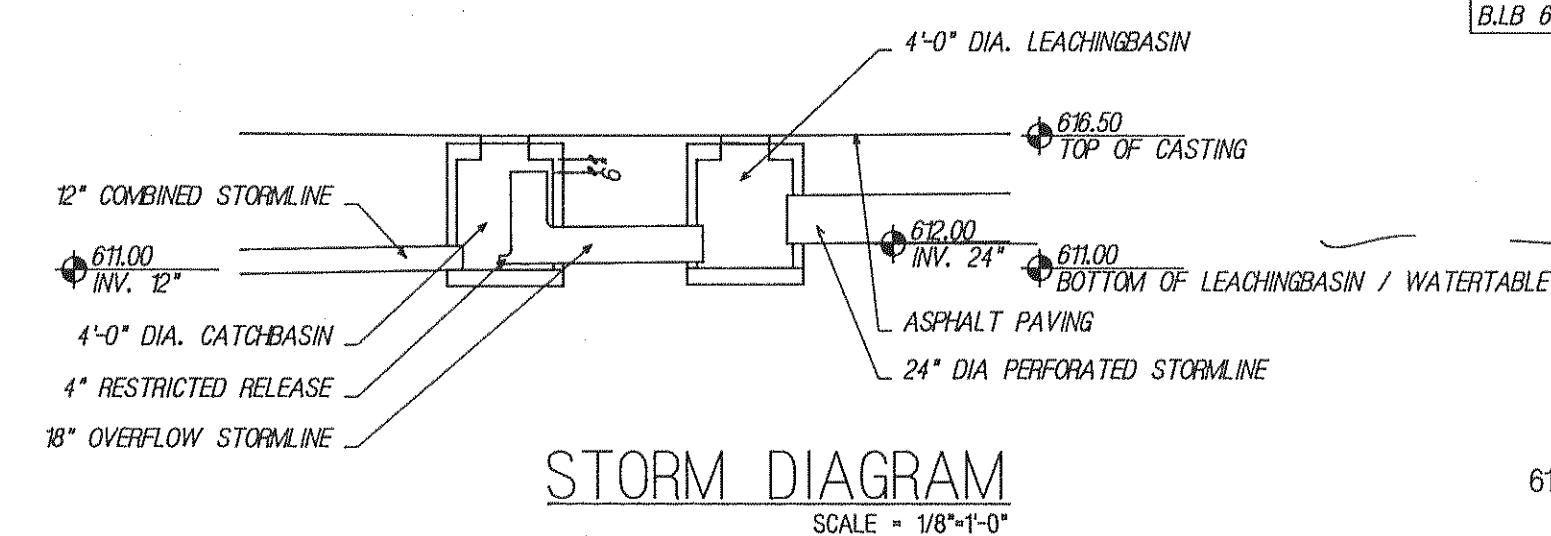

SITE PLAN

SCALE - 1/16"=1'-0"

A DESIGN ■■■■■■ BUILD PROJECT

SUTTER-VANER BROSCH
 10000 13TH AVE., N.E.
 SEATTLE, WA. 98120

BC

BOWERS & SONS CONSTRUCTION, INC.
 10000 13TH AVE., N.E. SUITE D
 SEATTLE, WA. 98120
 DEVELOPER-CONTRACTOR 362-5500

772-116 ARCHISTS

START PROJECT
01/04/94
CLIENT REVIEW
01/17/95
SITE DETENTION REVIEW
01/25/95
REVISION
03/08/95

MEINEKE MUFFLER / QUICK LUBE FACILITY
JAMES DAVIS
12200 James Street, Holland, Michigan, 49423

DRAWN BY
DARK
PROJECT NO.
103344
PLOT
03/08/95

SHEET NO.
A1.2
01-2 | site

PROJECT PERSONNEL

PLUMBING FIXTURE REVIEW

GENERAL NOTES

CODE REVIEW

<u>USE</u>	<u>AREA</u>	<u>FACTOR</u>	<u>CODE</u> <u>OCCUPANCY</u>
OFFICE	689 SQF	100 GROSS	7 PEOPLE
STORAGE	1,025 SQF	300 GROSS	3 PEOPLE
TOTAL OCCUPANCY LOAD = 10 PEOPLE			



SHEET NO.

A1

STOLLER-VANDEN BOSCH
AND ASSOCIATES INCORPORATED
76 EAST 8TH STREET SUITE 200
HOLLAND MICHIGAN 49423
ARCHITECTS
PHONE 616-494-7410
FAX 616-494-7415

START PROJECT
07/20/2022
CLIENT REVIEW

READY DAVINT

DRAWN BY
E.B.W.
PROJECT NO.
249153
PLOT
08/25/2022

SHEET NO.

A1

35